

ELECTRICAL SYMBOL LIST

 
NOTE: This is a standard symbol list and not all items listed may be used.

Lighting

- AREA LUMINAIRE ARM MOUNTED WITH POLE AND CONCRETE BASE. NUMBER OF HEADS AND CONFIGURATION INDICATED ON PLANS.

Calculation Summary						
Label	CalcType	Units	Avg	Max	Min	Avg/Min
SP Hall Blvd	Illuminance	FC	1.44	2.2	0.9	1.60
SP Westgate Dr	Illuminance	FC	1.71	2.3	1.0	1.71

1 SITE PLAN STREET LIGHTING PHOTOMETRICS



WESTGATE AND HALL
3775 SW HALL BOULEVARD, BEAVERTON, OR 97005

CEDARST

REVISION	DATE	REASON FOR ISSUE

SITE PLAN STREET LIGHTING PHOTOMETRICS

LAND USE

DATE: 4/19/2023 PROJECT NUMBER: 2022-1391

SHEET NUMBER: E1.02



38 NORTHWEST DAVIS, SUITE 300
 PORTLAND, OR 97209
 503.245.7100

1505 5TH AVE, SUITE 300
 SEATTLE, WA 98101
 206.576.1600

1014 HOWARD STREET
 SAN FRANCISCO, CA 94103
 415.252.7063

© ANKROM MOISAN ARCHITECTS, INC.

BEAVERTON TRADITIONAL ROUND GLOBE COLOR SCHEME
 K50 FIXTURE CAPITAL(1) KING TX FEDERAL GREEN
 BEAVERTON BRS HORIZONTAL BAND(1) STAINLESS STEEL (UN PAINTED)
 BEAVERTON BRS VERTICAL STRUTS (4) KING SM CHROME SILVER
 BEAVERTON BRS EMBLEM (4) KING SM CHROME SILVER
 VENTED FINIAL(1) KING TX FEDERAL GREEN


REV.	ALTERATION	DATE	BY
A	PAINT SCHEME ADDED	04/04/19	T.B
B	"B2AF(ETCHED)" CHANGED TO "B2VC"	02/07/21	A.A.
C	NATURAL ALUM. REPLACED WITH ST.STL.	02/20/21	A.A.

LUMINAIRE SPECIFICATIONS

CATALOGUE NO.: KG20R-B2VC-III-60(SSL)
 -1042-120:277-K50-BRS-PBC-4K

QUANTITY:
 OPTICAL SYSTEM: BAFFLED TOWER VISUAL COMFORT
 IES LTG. CLASS: TYPE III
 WATTAGE: 60W
 LIGHT SOURCE: SOLID STATE LIGHTING
 SERIES: 1042
 LINE VOLTAGE: 120:277V
 CCT: 4000K
 POLE ADAPTOR: K50
 PAINT: SEE PAINT SCHEME
 OPTIONS: C/W PHOTO BUTTON CELL & BEAVERTON RING & STRUTS (SEE PAINT SCHEME)

OPTIONS
 QUICK DISCONNECT
 TERMINAL BLOCK

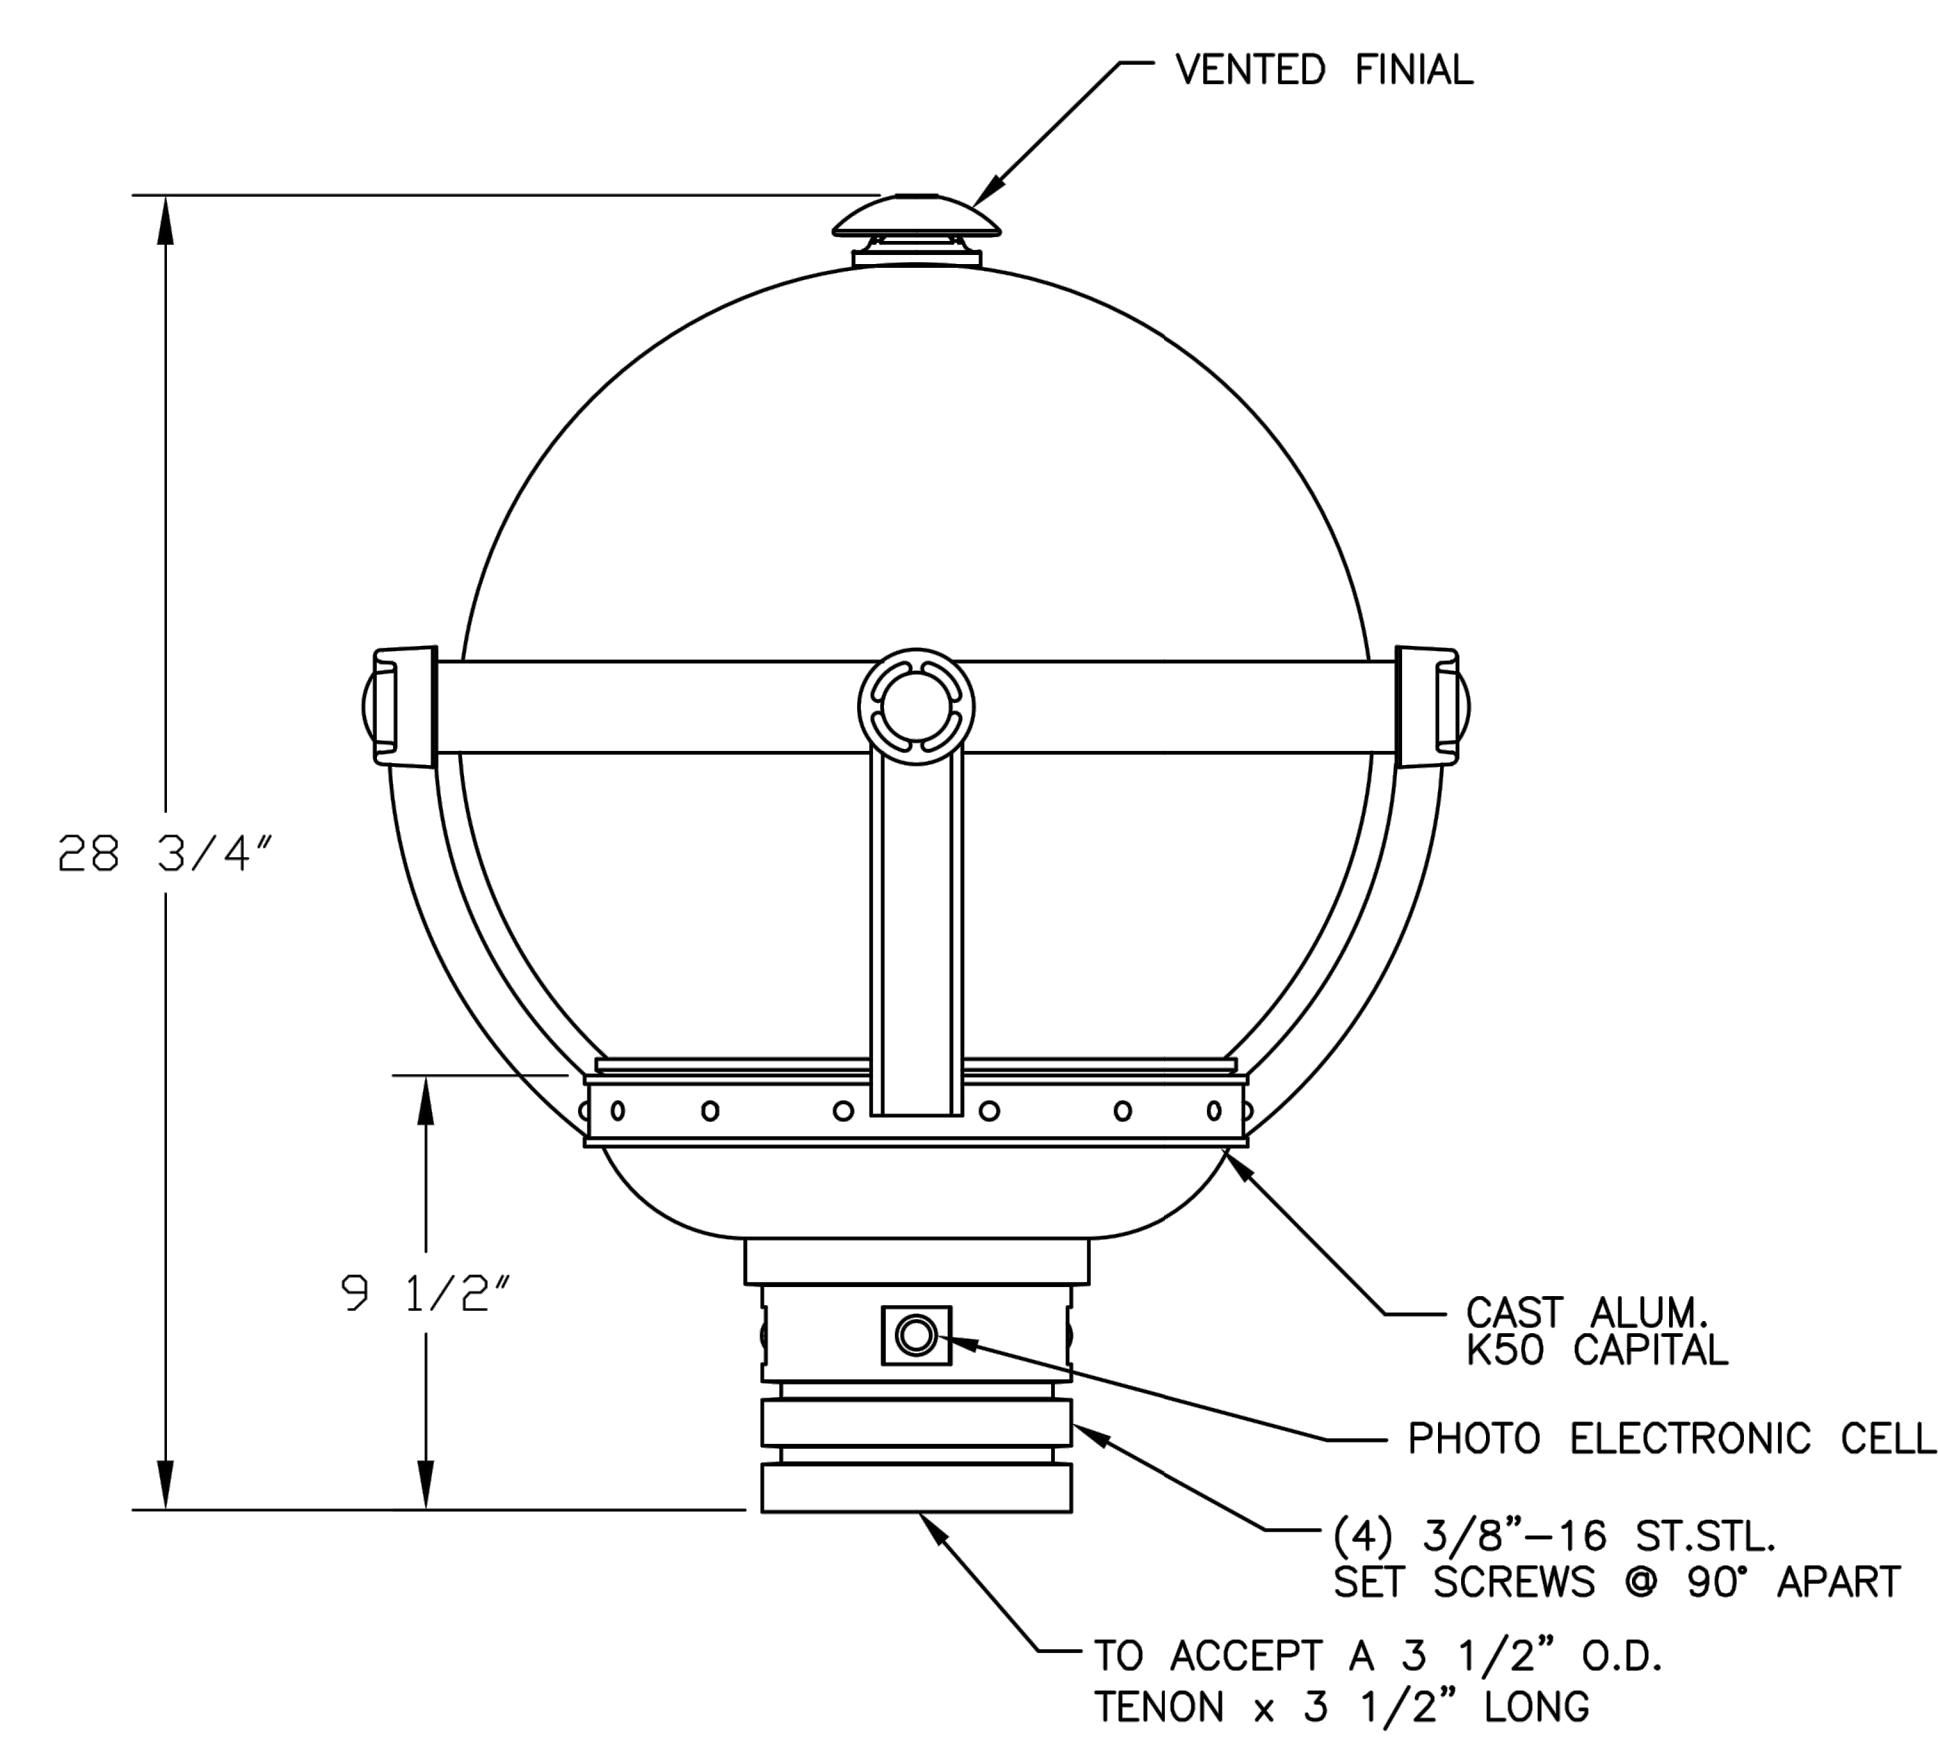

CUSTOMER APPROVAL & DATE: _____

 STRESSCRETE GROUP King Luminaire • StressCrete • Est. 1953	<i>Manufacturing Locations:</i>	
	Burlington, Ontario 1-800-268-7809	
	Northport, Alabama 1-800-435-6563	
	Atchison, Kansas 1-800-837-1024	
	Jefferson, Ohio 1-800-268-7809	

CUSTOMER ORDER No: _____

PROJECT/CUSTOMER: CITY OF BEAVERTON

KING U.S. ORDER No: _____

DRAWN BY:	AT:	CHECKED BY:	DATE:	REVISION:
A. ALVELA	SC1		02/26/19	C

DRAWING TYPE:	DRAWING NUMBER:
APPROVAL/MFG. DWG.	KG20R-B2AF-K50-BRS-PBC-1

WESTGATE AND HALL
 3775 SW HALL BOULEVARD, BEAVERTON, OR 97005

CEDARST

REVISION	DATE	REASON FOR ISSUE

DETAILS AND CUTSHEETS

LAND USE

DATE	PROJECT NUMBER
4/19/2023	2022-1391

SHEET NUMBER **E7.01**

